



PANDA EXPRESS, INC.
1683 Walnut Grove Ave.
Rosemead, California
91770
Telephone: 626.799.9898
Facsimile: 626.372.8288

All ideas, designs, arrangement and plans indicated or represented by this drawing are the property of Panda Express Inc. and were created for use on this specific project. None of these ideas, designs, arrangements or plans may be used by or disclosed to any person, firm, or corporation without the written permission of Panda Express Inc.

REVISIONS:

ISSUE DATE:


PERMIT/BID ISSUE	09-20-2021

DRAWN BY: -

PANDA PROJECT #: - S8-21-D8118

PANDA STORE #: - D8118

ARCH PROJECT #: - 20185

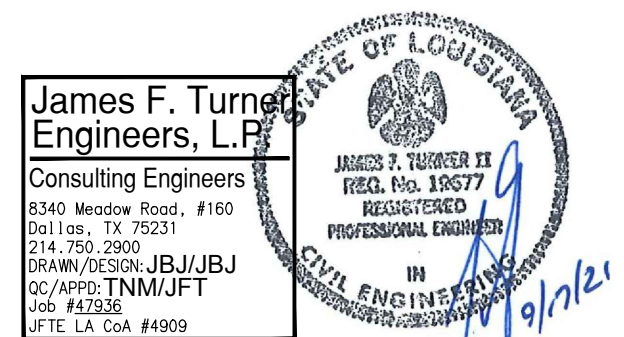


PANDA EXPRESS
TRUE WARM & WELCOME
911 N. SERVICE RD.
RUSTON, LA 71270

E-401


ELECTRICAL DETAILS, DIAGRAMS

TRUE WARM & WELCOME 2300 R5

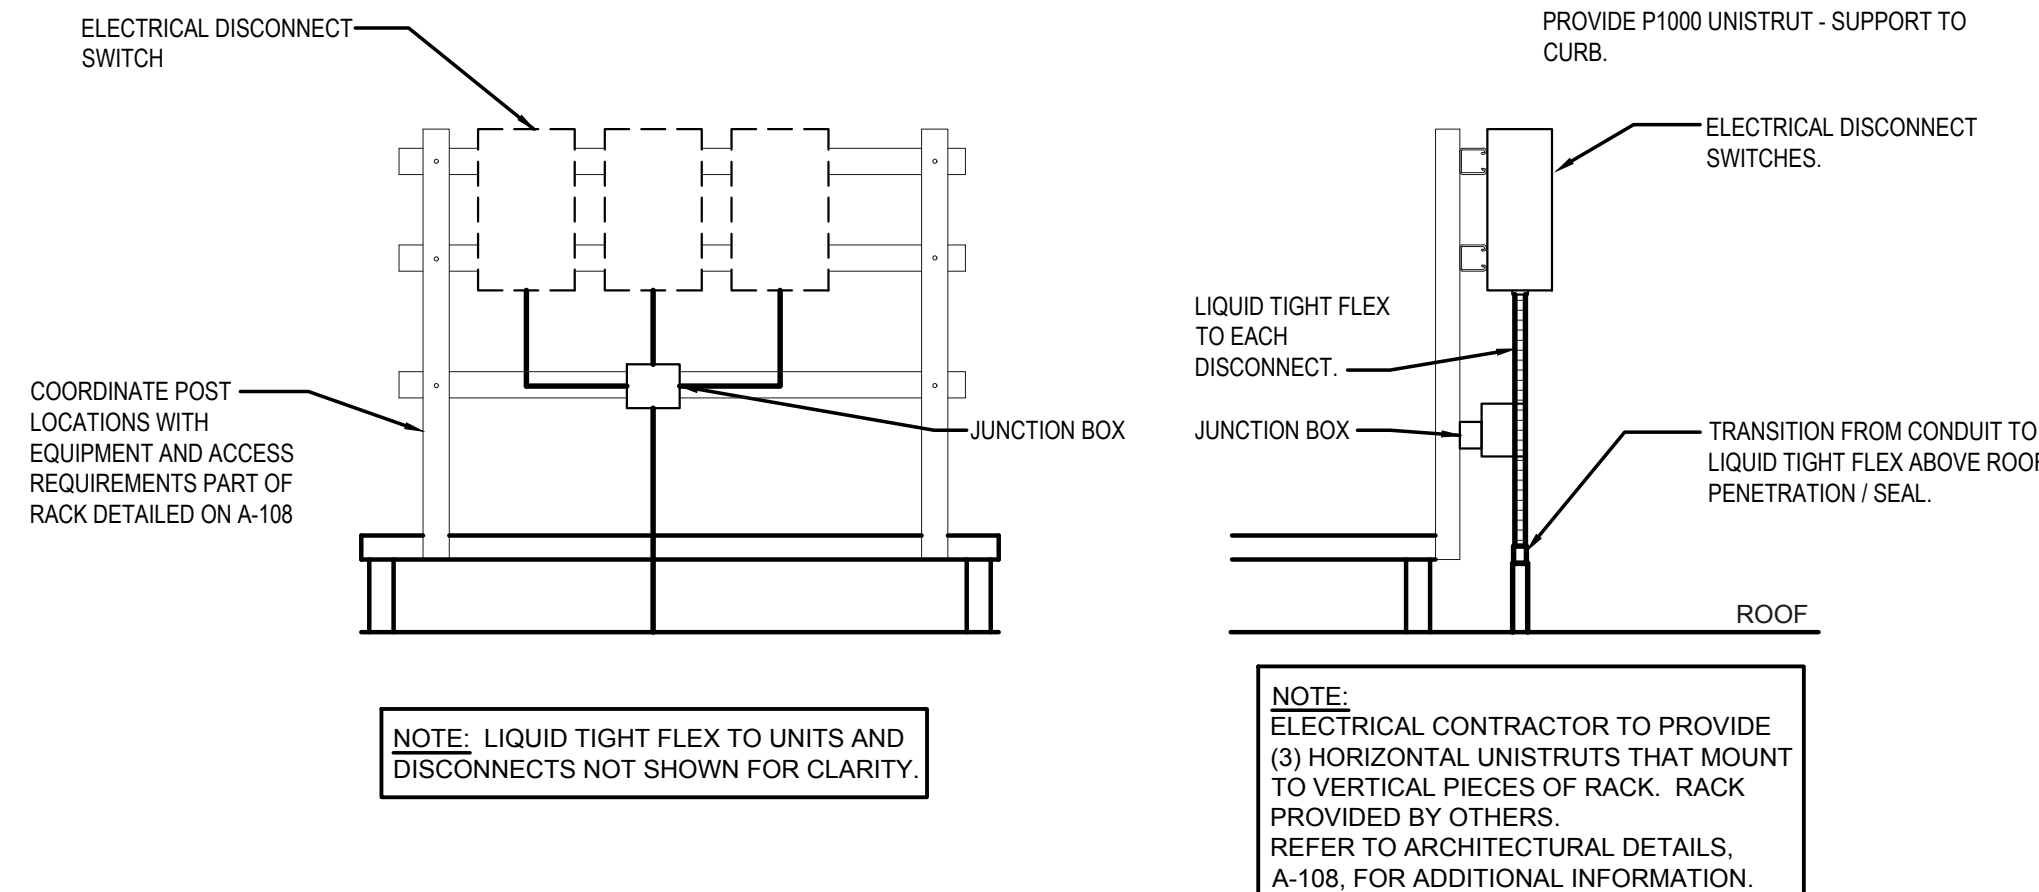


EQUIPMENT DISCONNECT SWITCH SUPPORT 2

NOT TO SCALE E-401

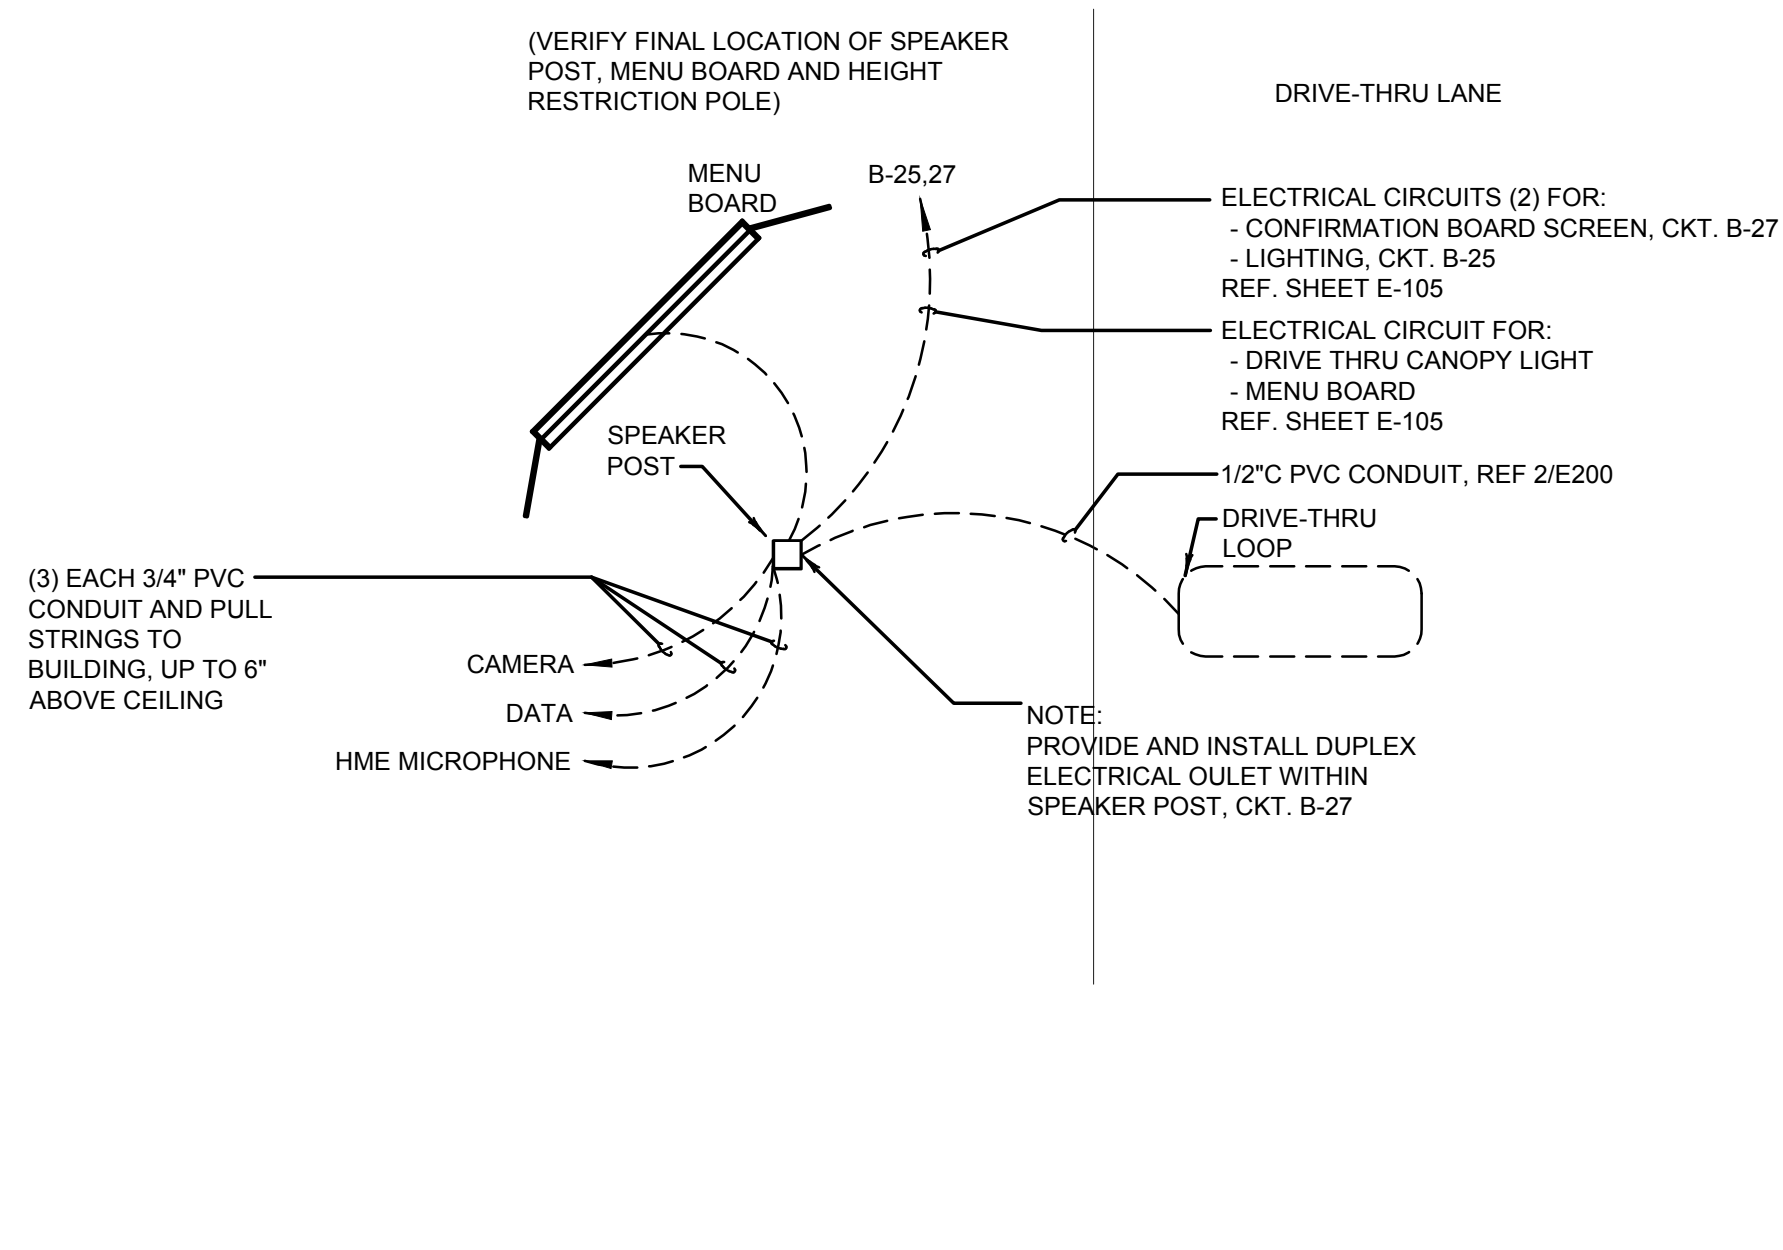

MENU BOARD & SENSOR LOOP 1

E-401

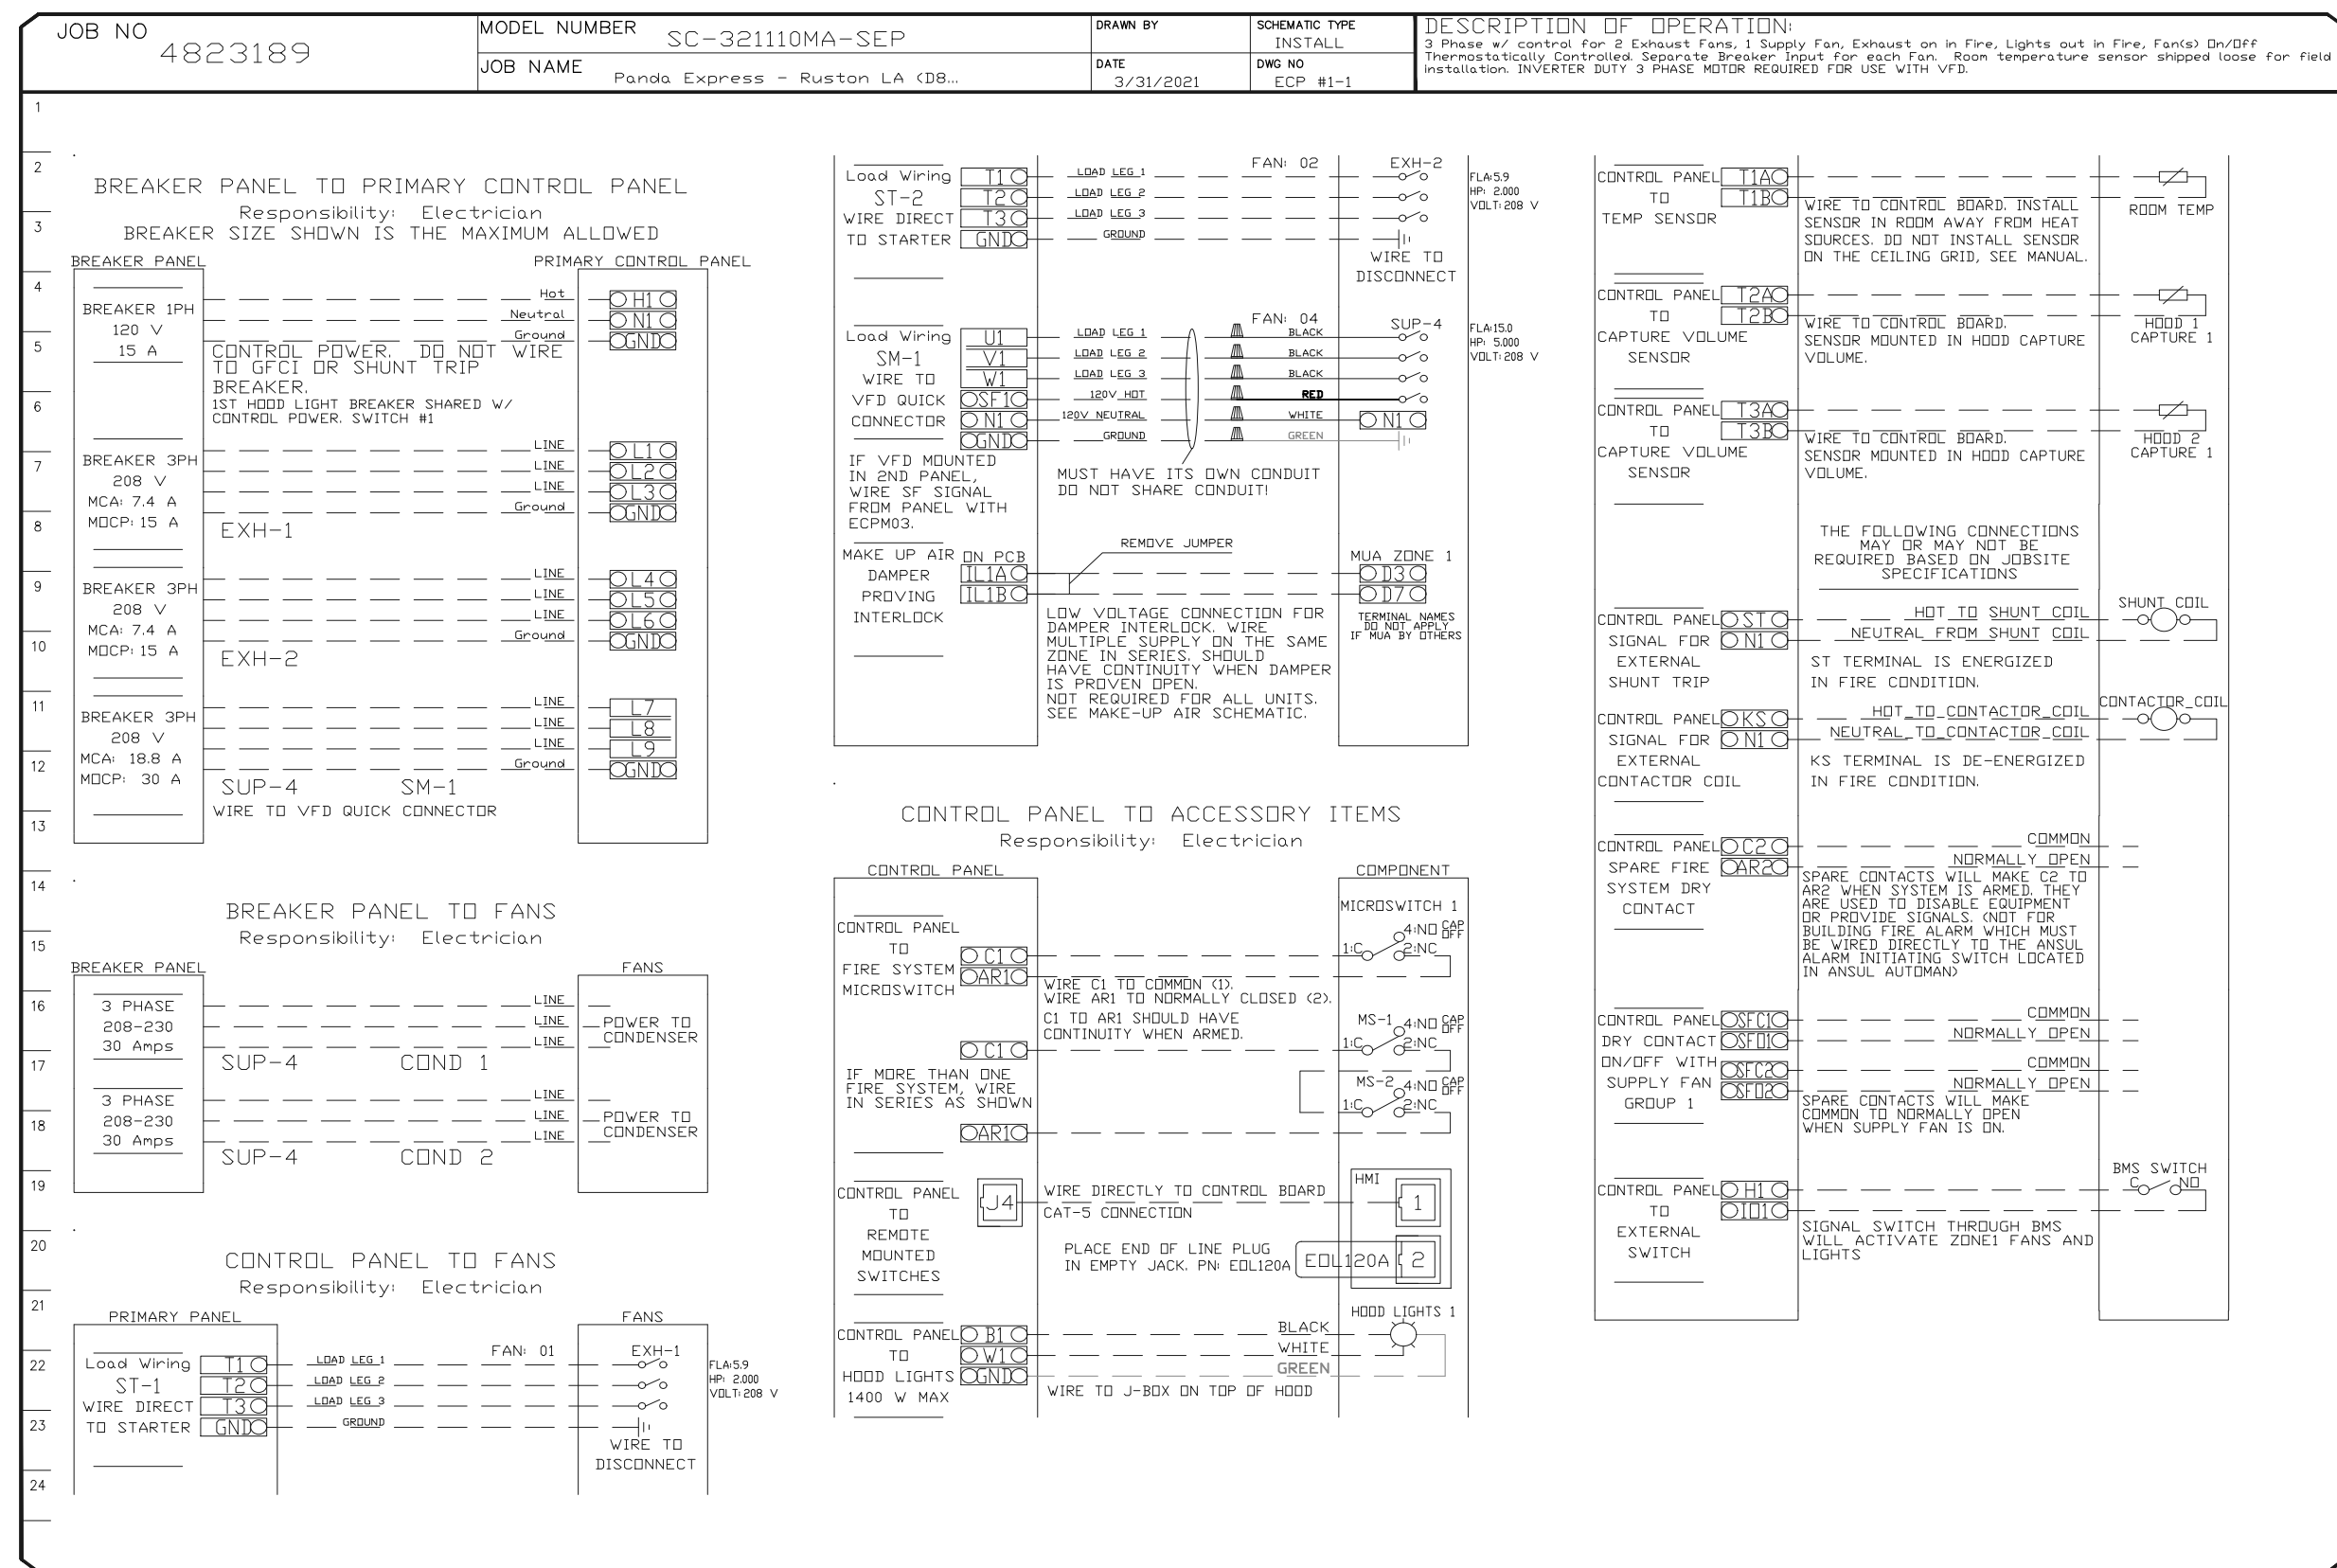

KITCHEN EXHAUST SYSTEM DIAGRAM 3

NOT TO SCALE E-401

PERMIT/BID SET