



All ideas, designs, arrangement and plans indicated or represented by this drawing are the property of Panda Express Inc. and were created for use on this specific project. None of these ideas, designs, arrangements or plans may be used by or disclosed to any person, firm, or corporation without the written permission of Panda Express Inc.

REVISIONS:

[illegible]

DRAWN BY: JEL

PANDA PROJECT #: - S8-22-D8698  
C&P PROJECT #: - 2210806




03.04.2022

**PANDA EXPRESS**  
TRUE WARM AND WELCOME 2200  
3030 DERITA ROAD  
CONCORD, NC 28027


E-401

ELECTRICAL DETAILS, DIAGRAMS

TRUE WARM &amp; WELCOME 2200 R4

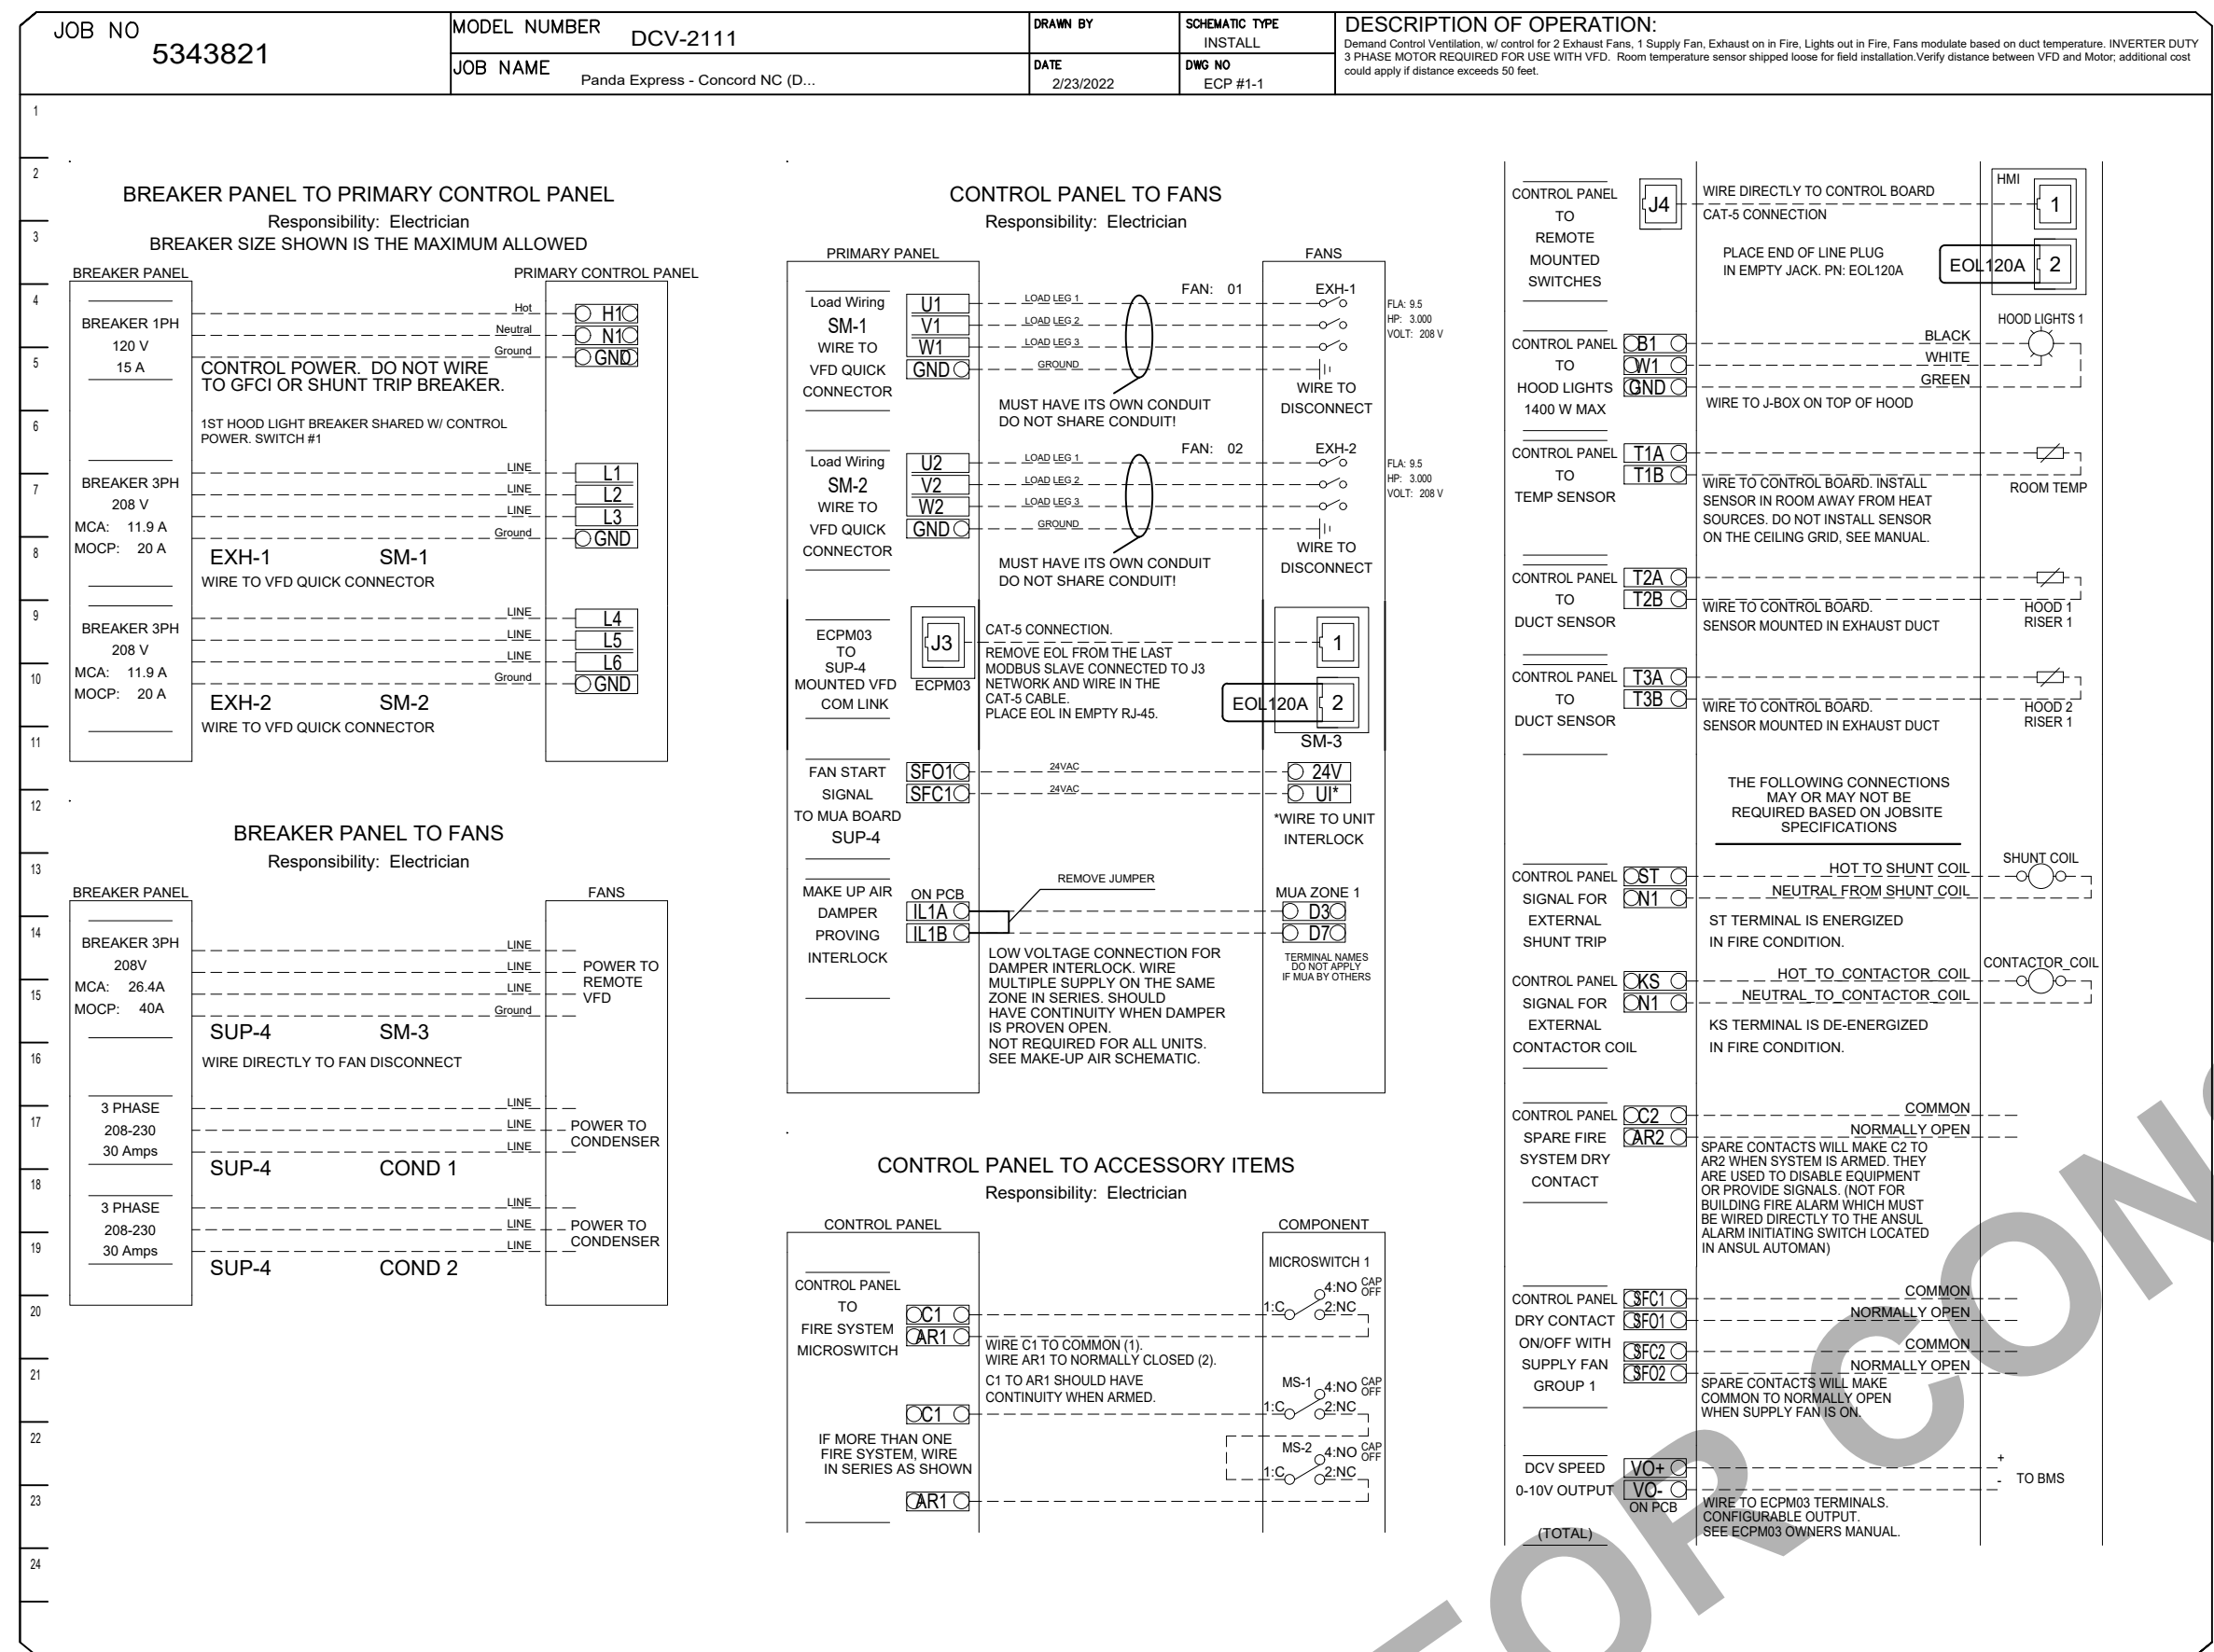

NOT TO SCALE | E-401

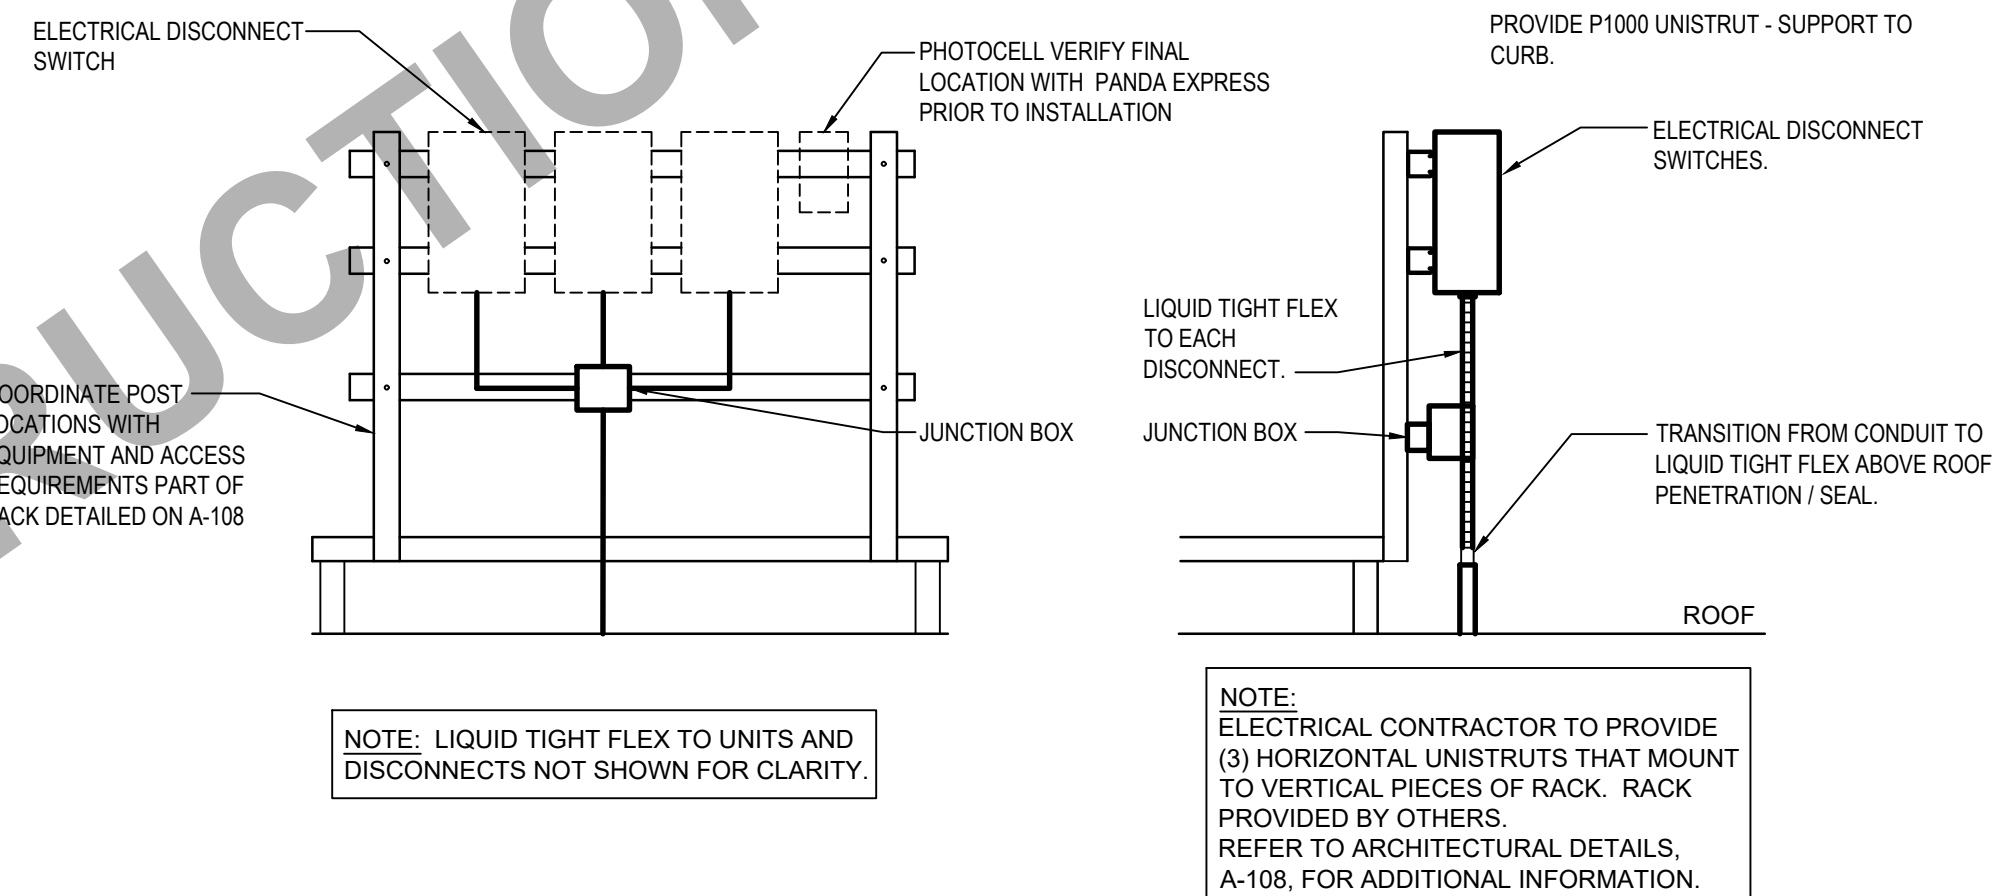


EQUIPMENT DISCONNECT SWITCH SUPPORT

NOT TO SCALE | E-401

2

E-401

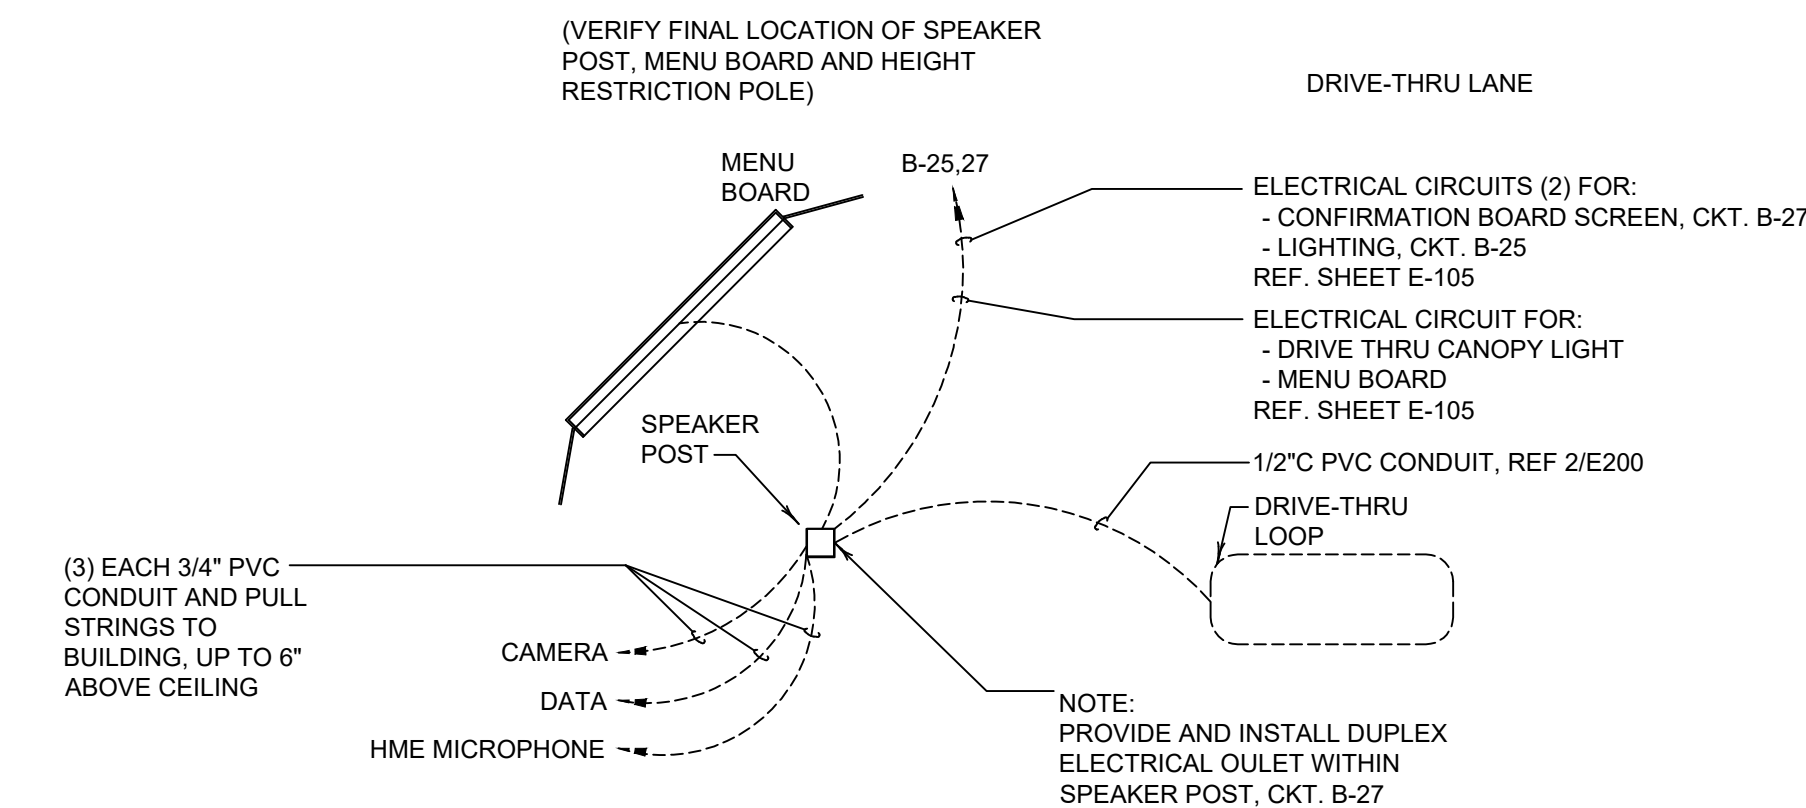

## MENU BOARD & SENSOR LOOP

|   |
|---|
| 1 |
|---|

E-401